

 

 












GENERAL DRAINAGE LAYOUT
SCALE 1:250

Legend

 
-  Guard House
-  Cadastral Boundary
-  Tarmac Road
-  Gravel Road
-  Chainlink Fence
-  EXISTING DRAINAGE
-  River Edge
-  1.5" Water Pipe
-  Gate
-  Football field superficial drainage 0.4%
-  Athletic track superficial drainage 0.8%
-  Drainage slope 1%
-  Drainage with concrete cover slope 1%
-  Drainage with grating cover slope 1%



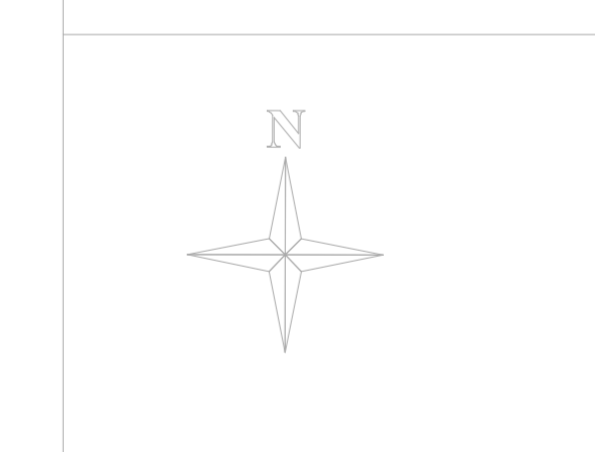Notes
1. BLACK COTTON SOIL TO BE EXCAVATED & DRAINED TO BE BACKFILLED TO A DEPTH OF 100MM, SLOPPED AS PER THE LAYOUTS

 



 
 

 
 
 
 
 
Client
MAKUENI COUNTY GOVERNMENT
DESIGNED BY
KJS

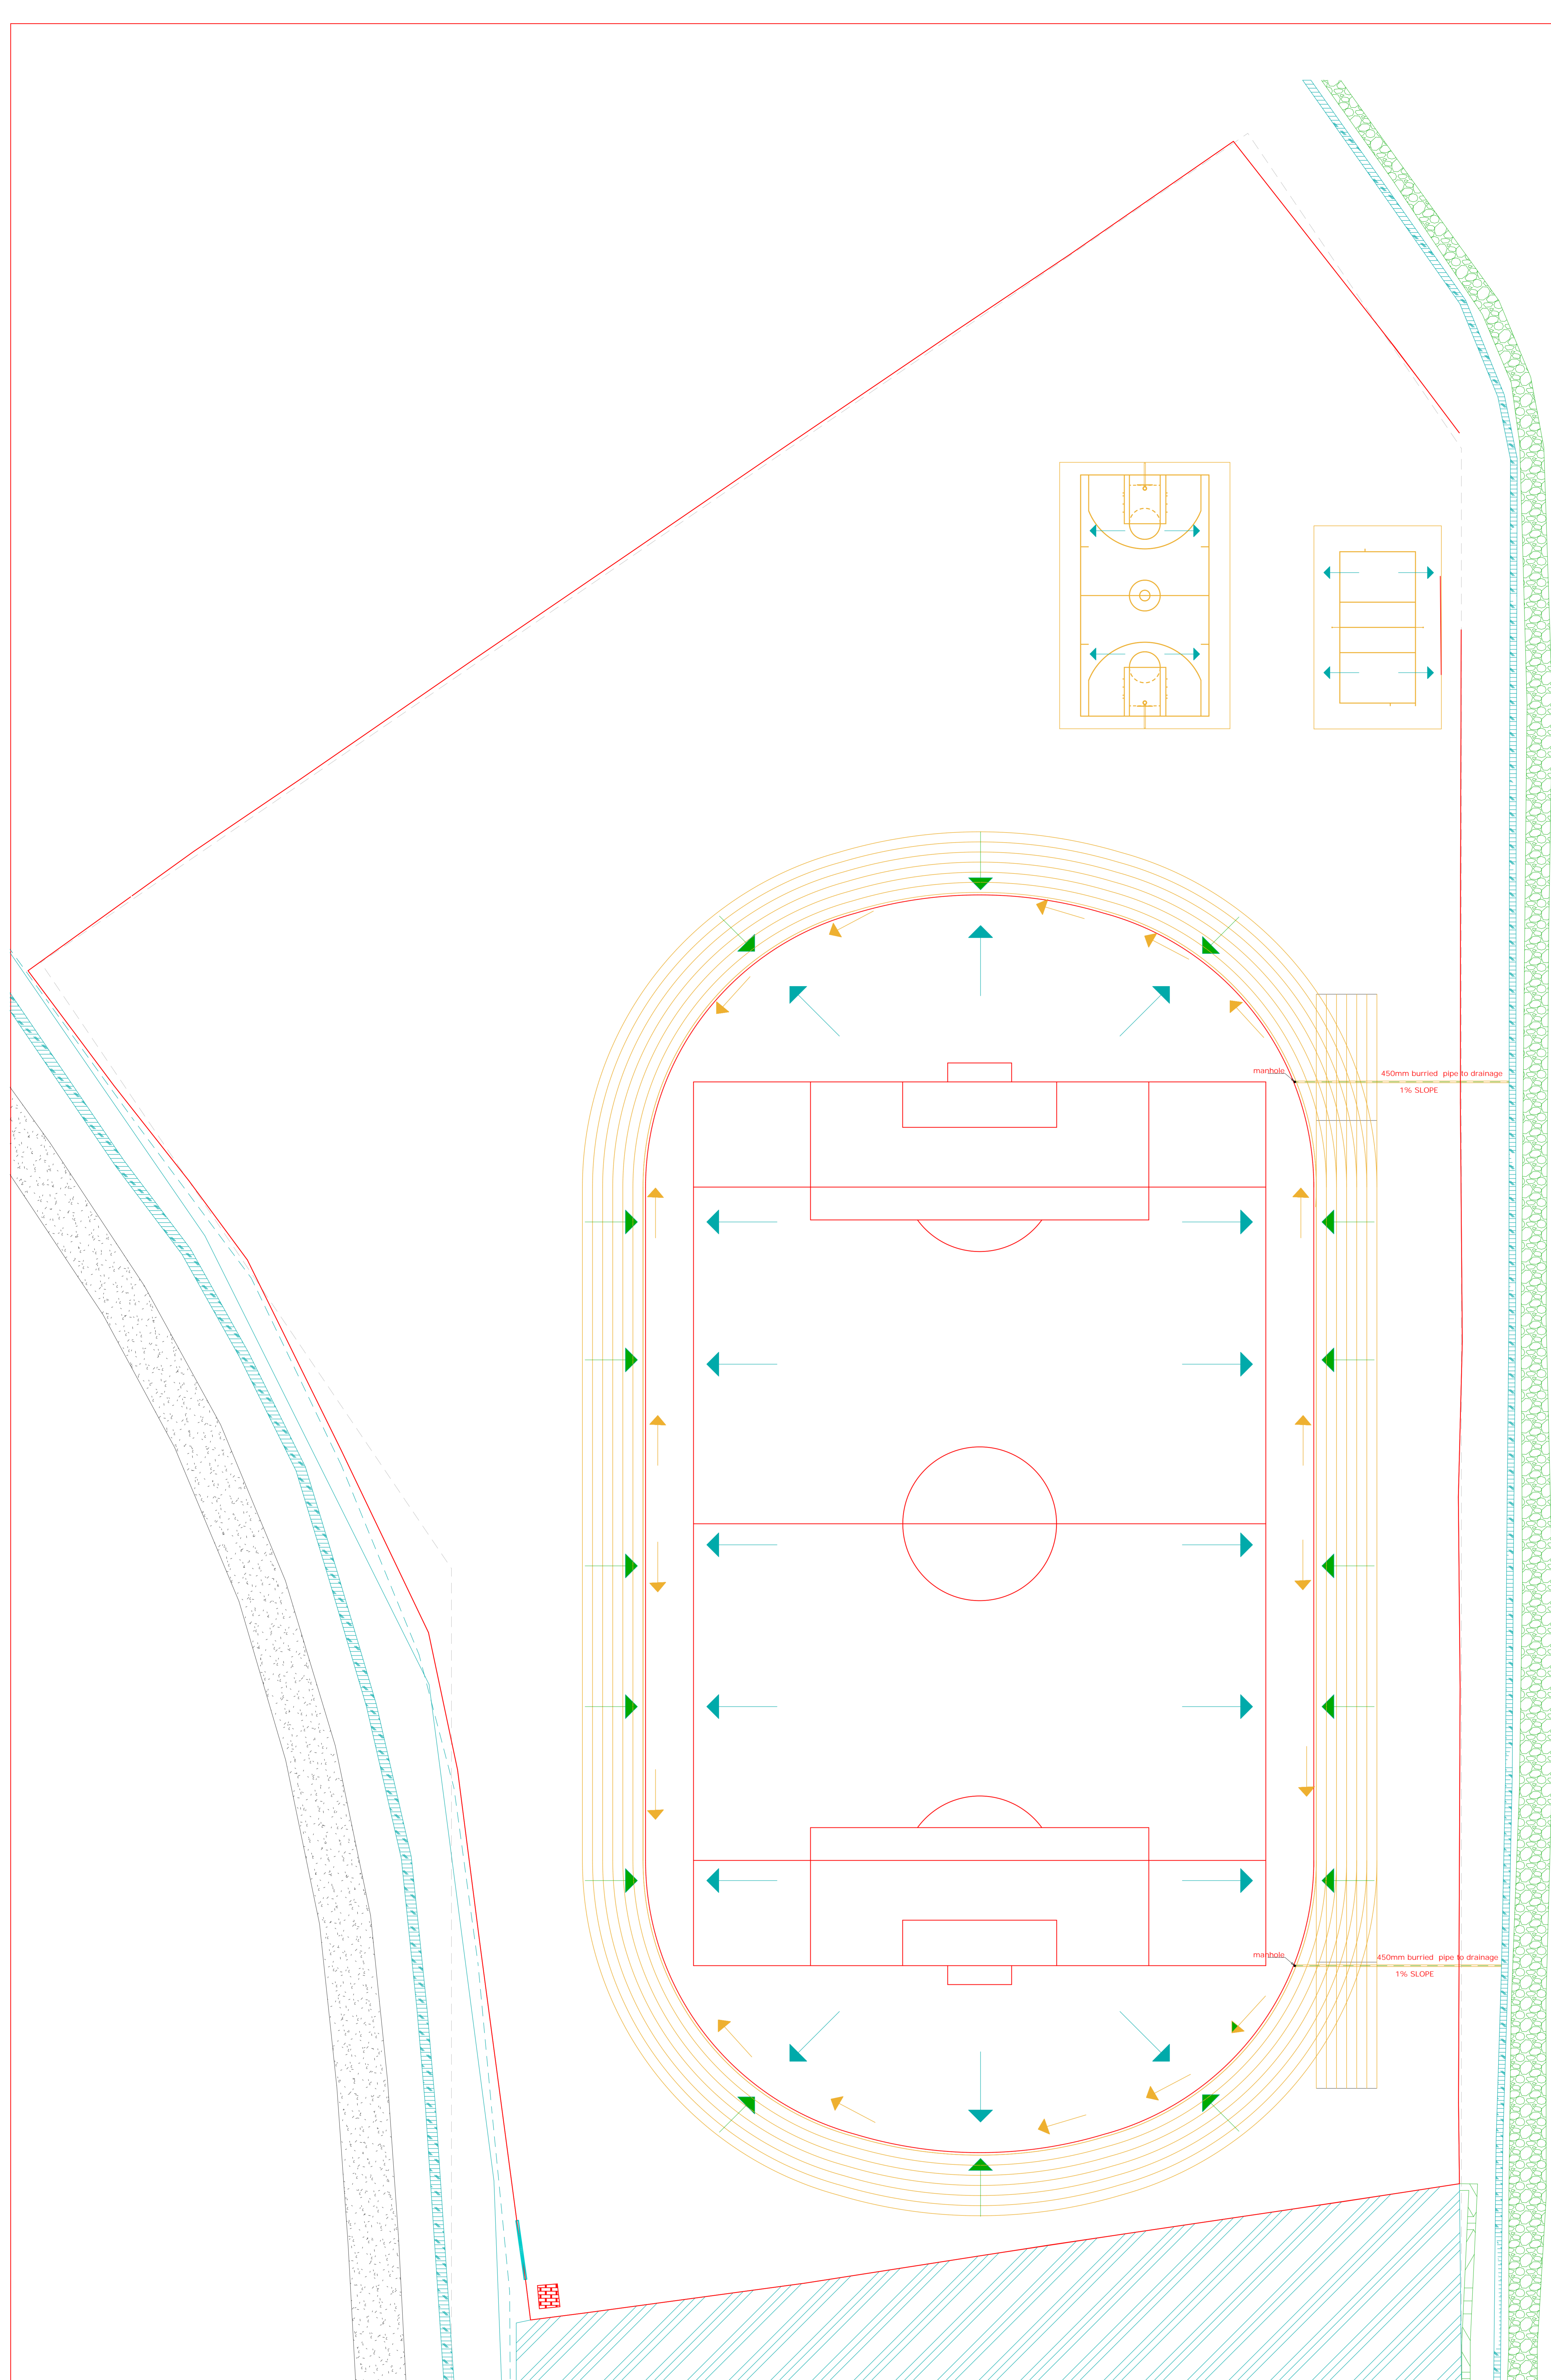Date	July 2024
Drawn by	KJS



FOOTBALL,RUNNING TRACK BASKETBALL & VOLLEYBALL DRAINAGE LAYOUT
SCALE 1:250

Legend


-  Guard House
-  Cadastral Boundary
-  Tarmac Road
-  Gravel Road
-  Chainlink Fence
-  EXISTING DRAINAGE
-  River Edge
-  1.5\"
-  Gate
-  Football field superficial drainage 0.4%
-  Athletic track superficial drainage 0.8%
-  Drainage slope 1%

Notes


1. BLACK COTTON SOIL TO BE EXCAVATED & DRAINED TO BE BACKFILLED TO A DEPTH OF 100MM, SLOPPED AS PER THE LAYOUTS

Client
MAKUENI COUNTY GOVERNMENT
DESIGNED BY
KJS


Date	July 2024
Drawn by	KJS

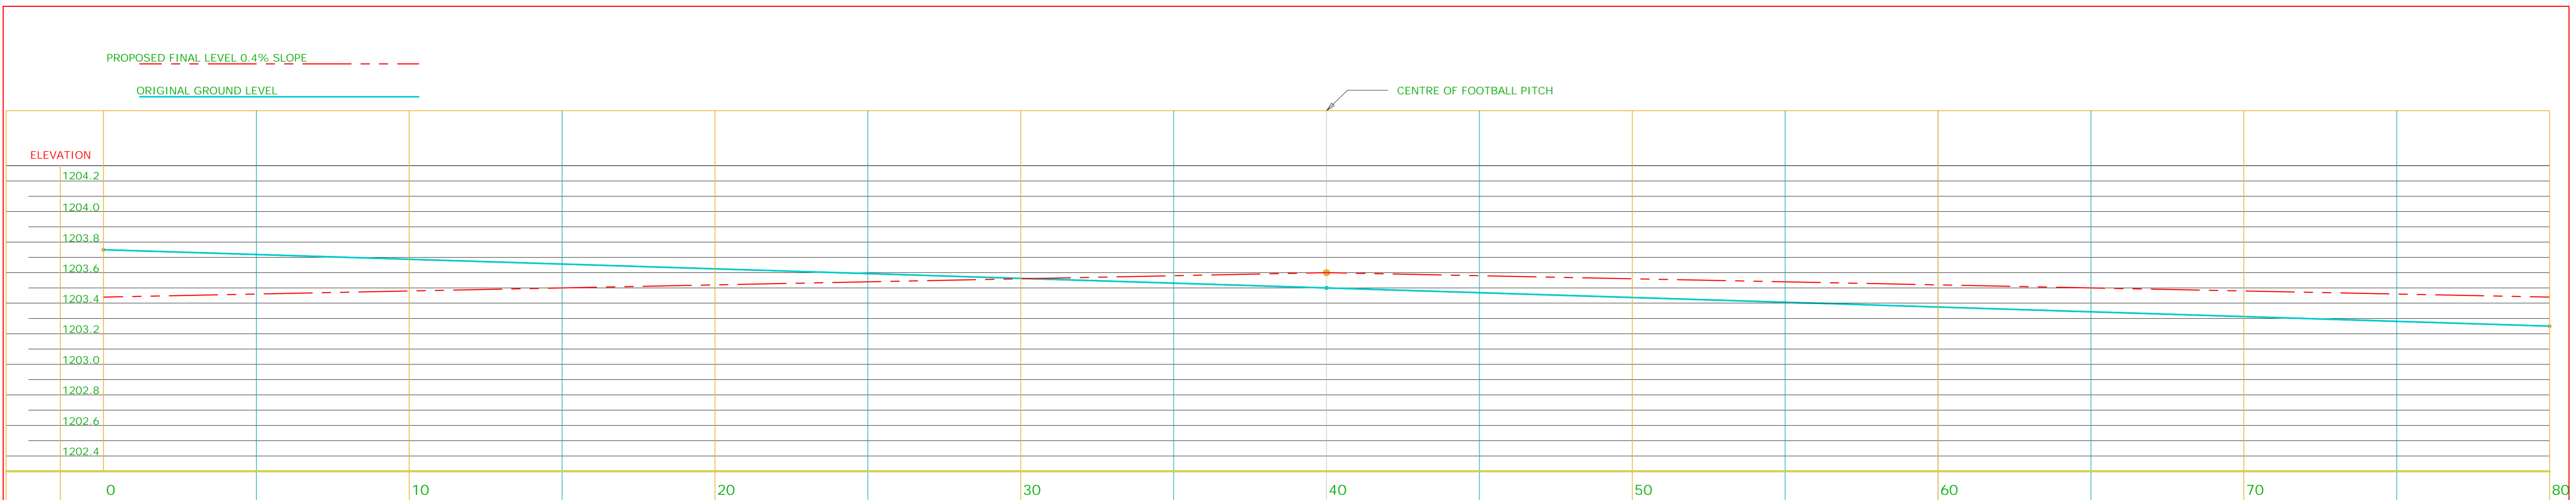






SECTION X-X THROUGH THE FOOTBALL PITCH
SCALE 1:100

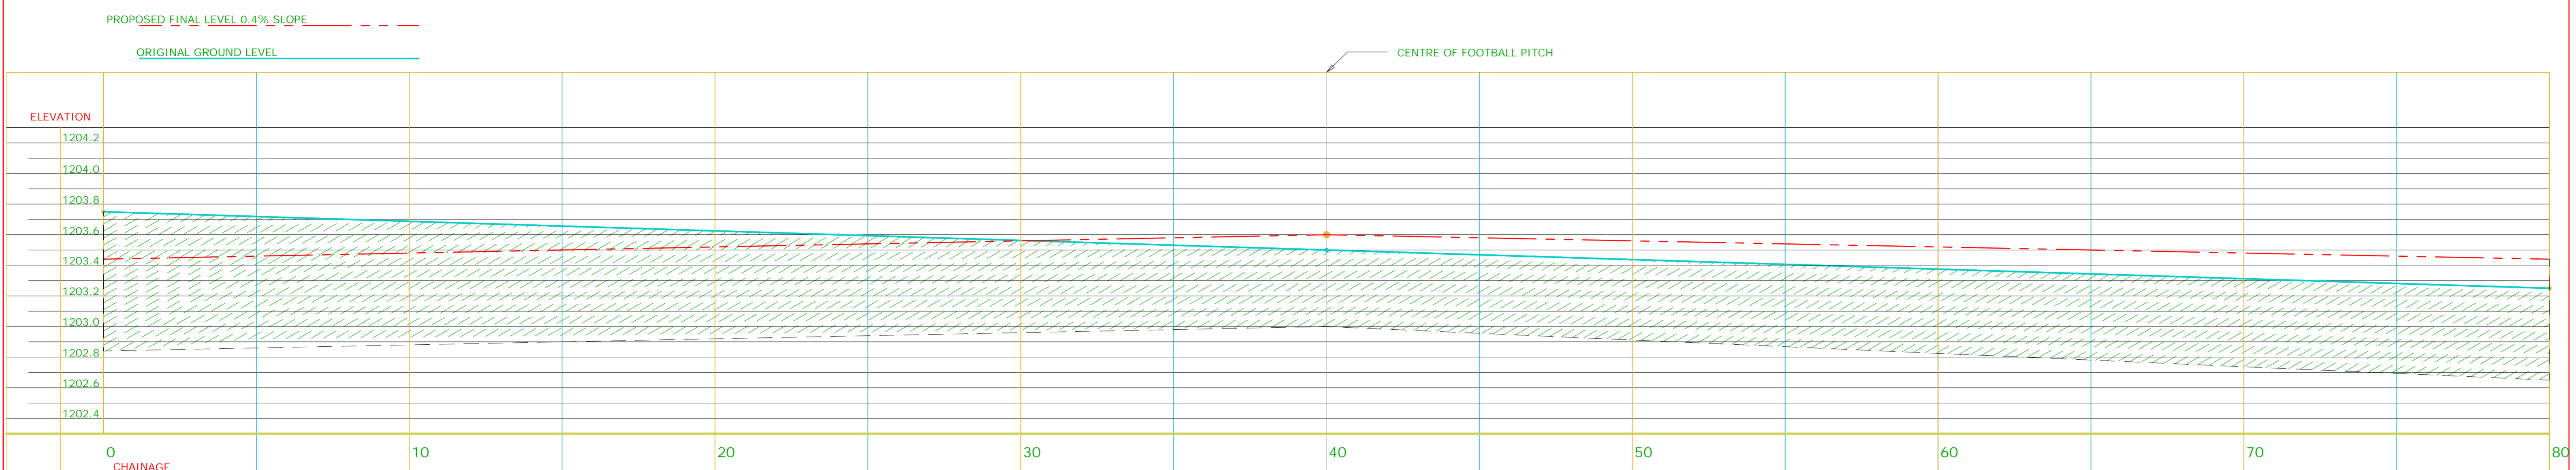

CUT
SCALE 1:100

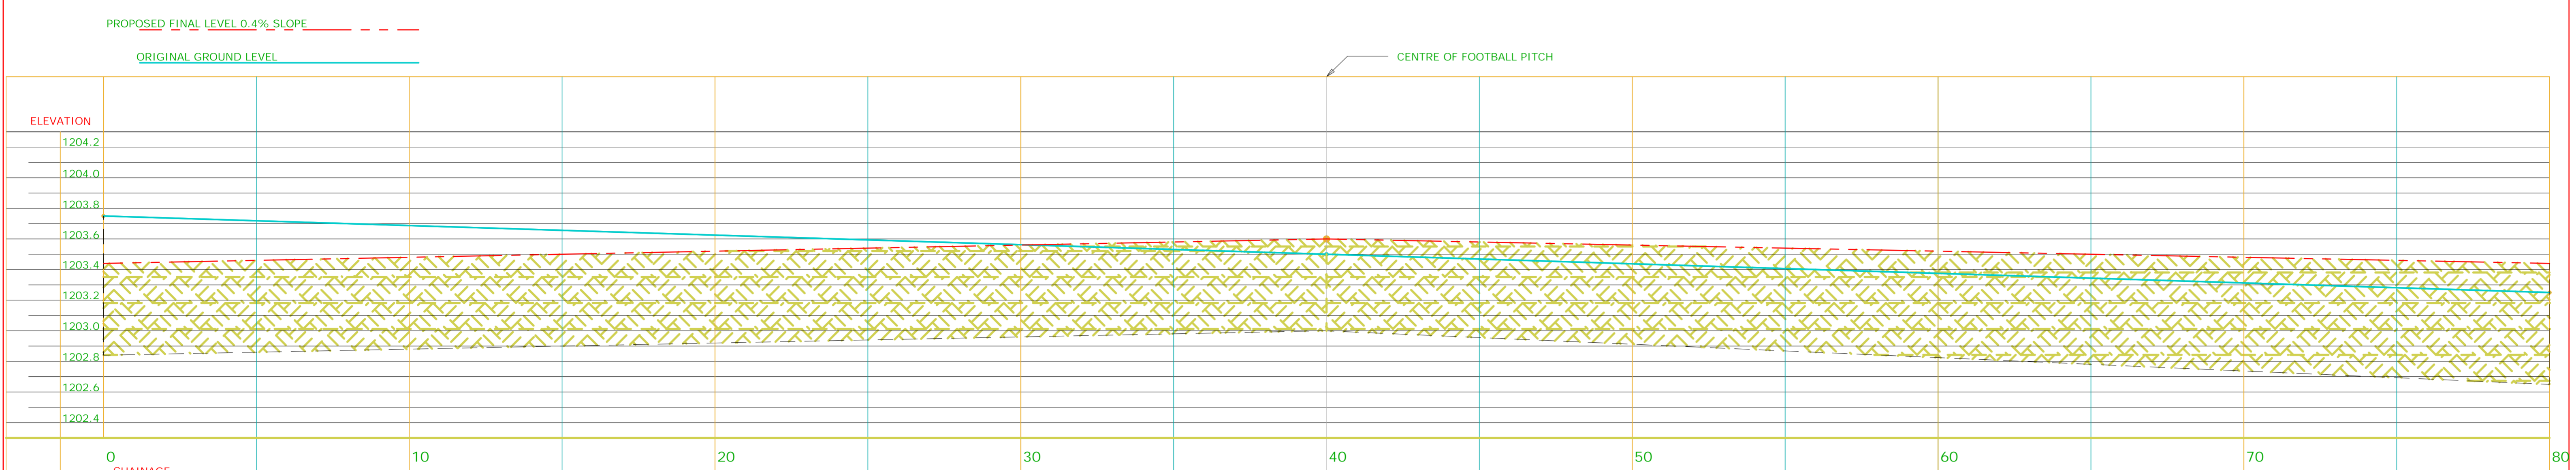

FILL
SCALE 1:100

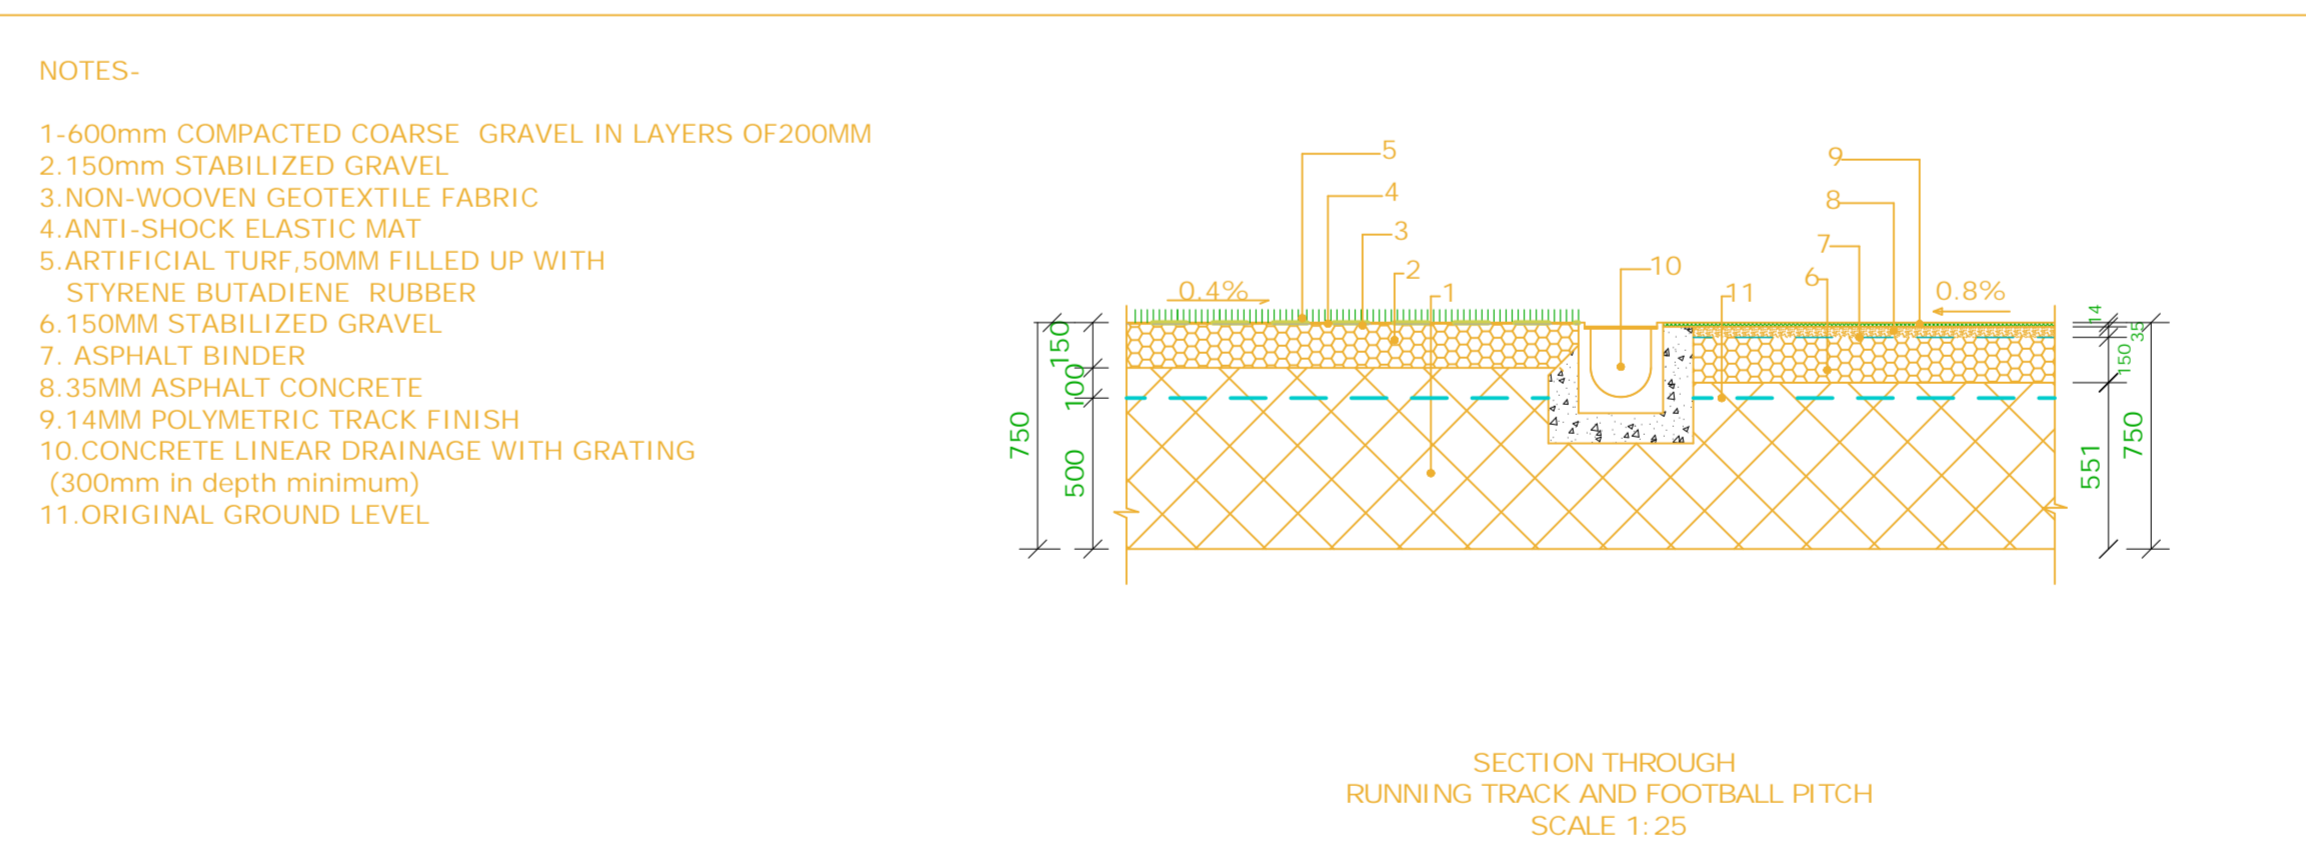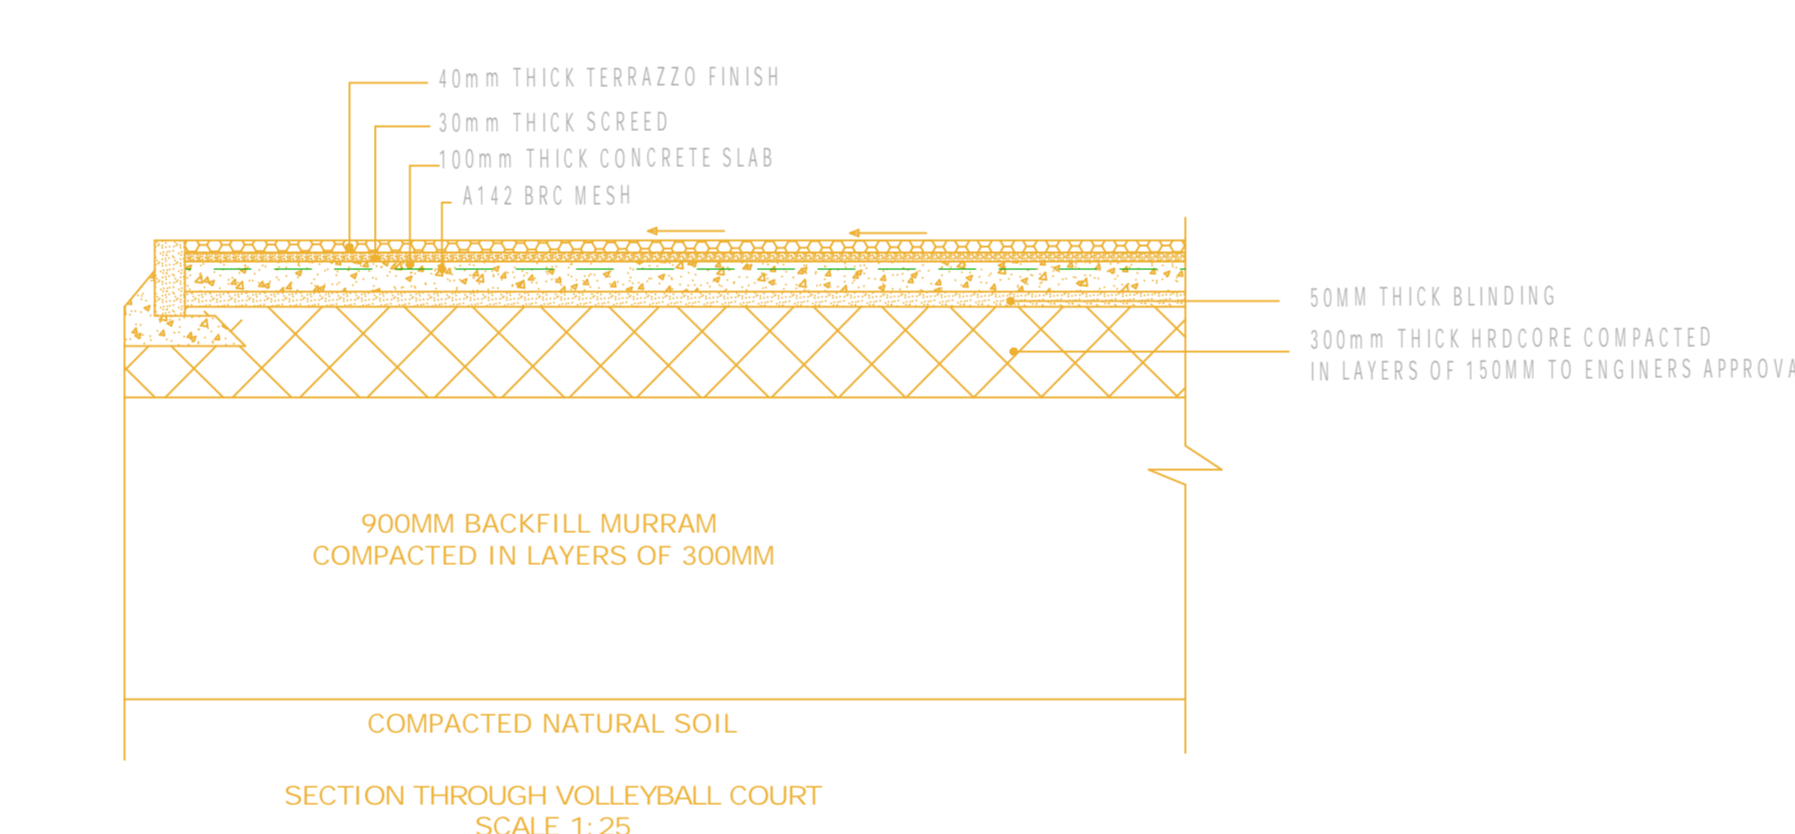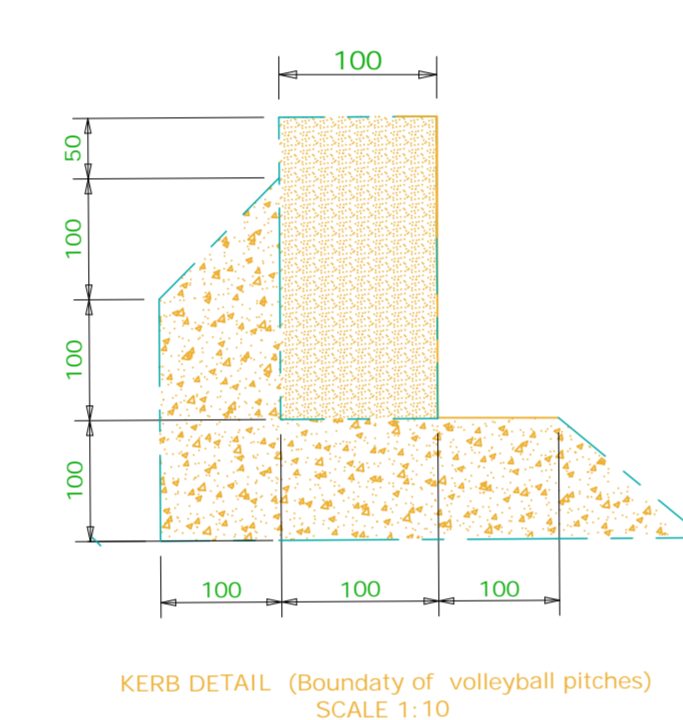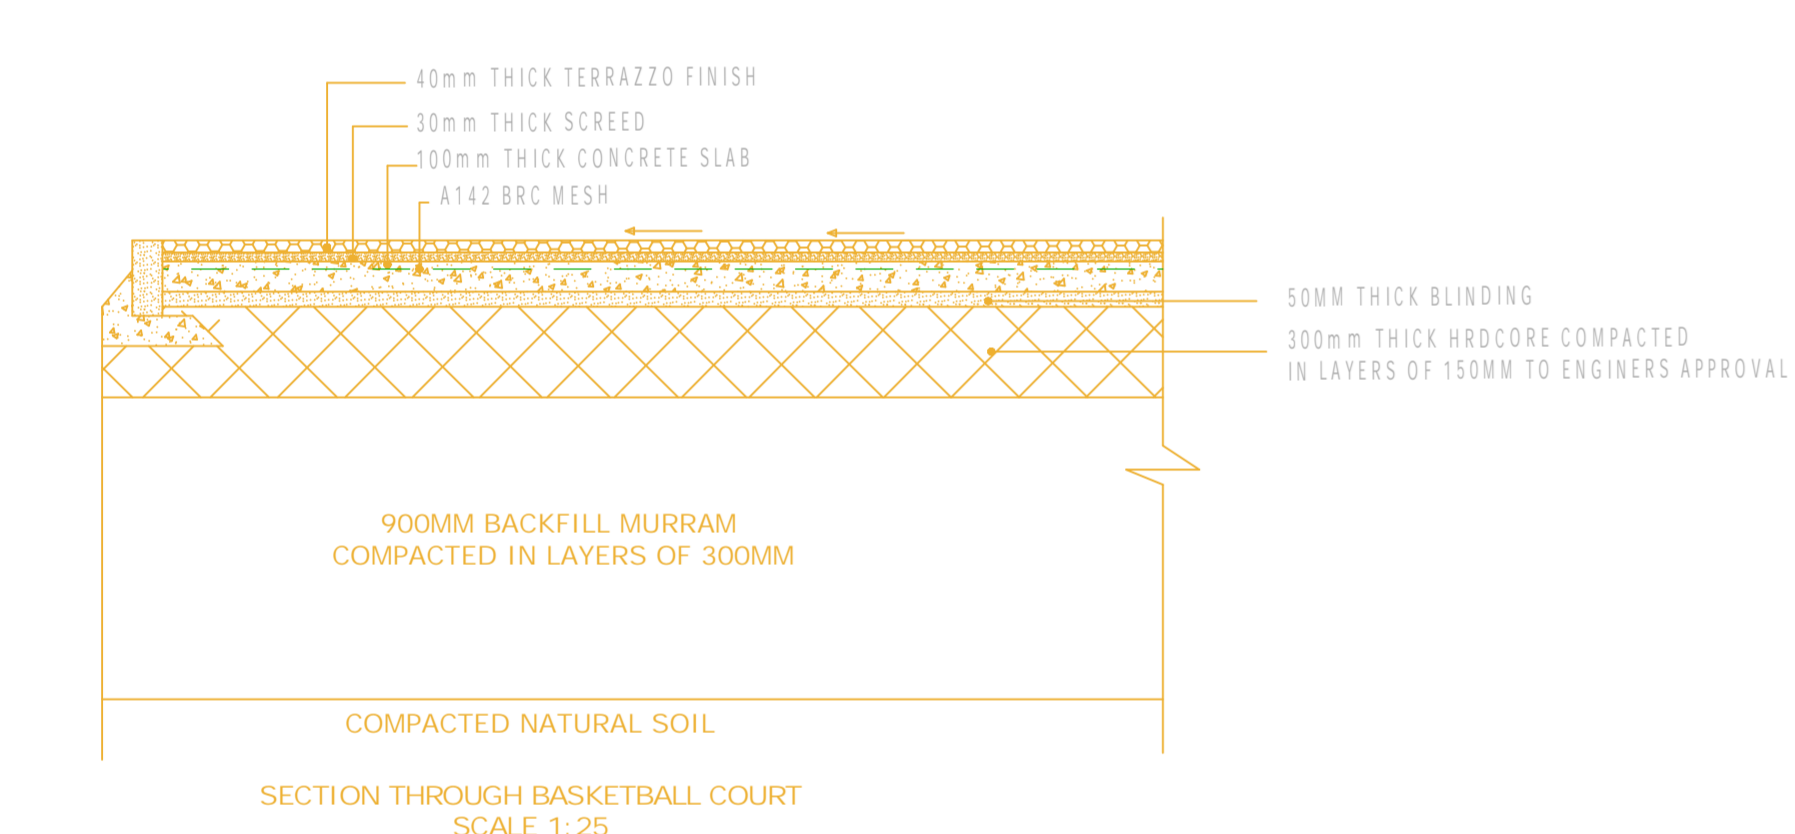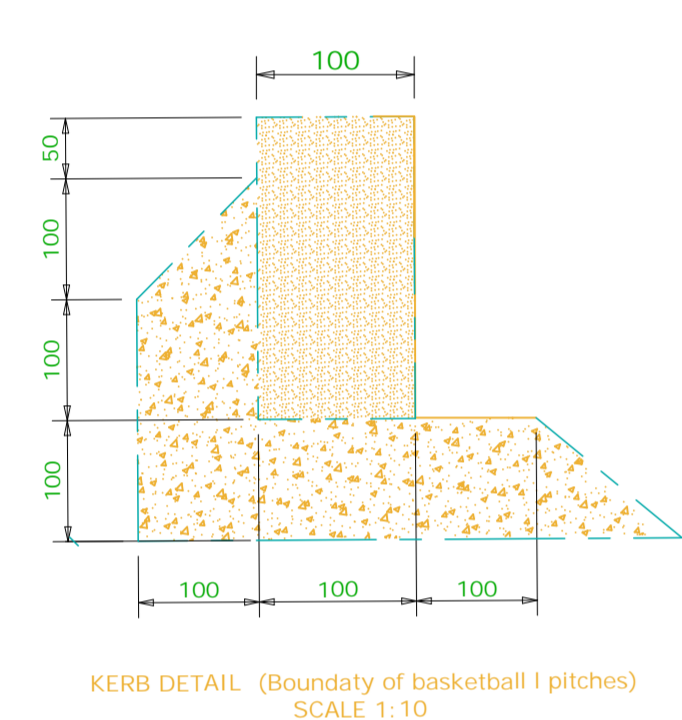

N


Notes

- 1-BLACK COTTON SOIL TO BE EXCAVATED TO A DEPTH OF 50MM
- 2-GRAVEL TO BE BACKFILLED TO A DEPTH OF 100MM, SLOPPED AS PER THE LAYOUTS


Client
MAKUENI COUNTY GOVERNMENT

DESIGNED BY
KJS


Date	July 2024
Drawn by	KJS

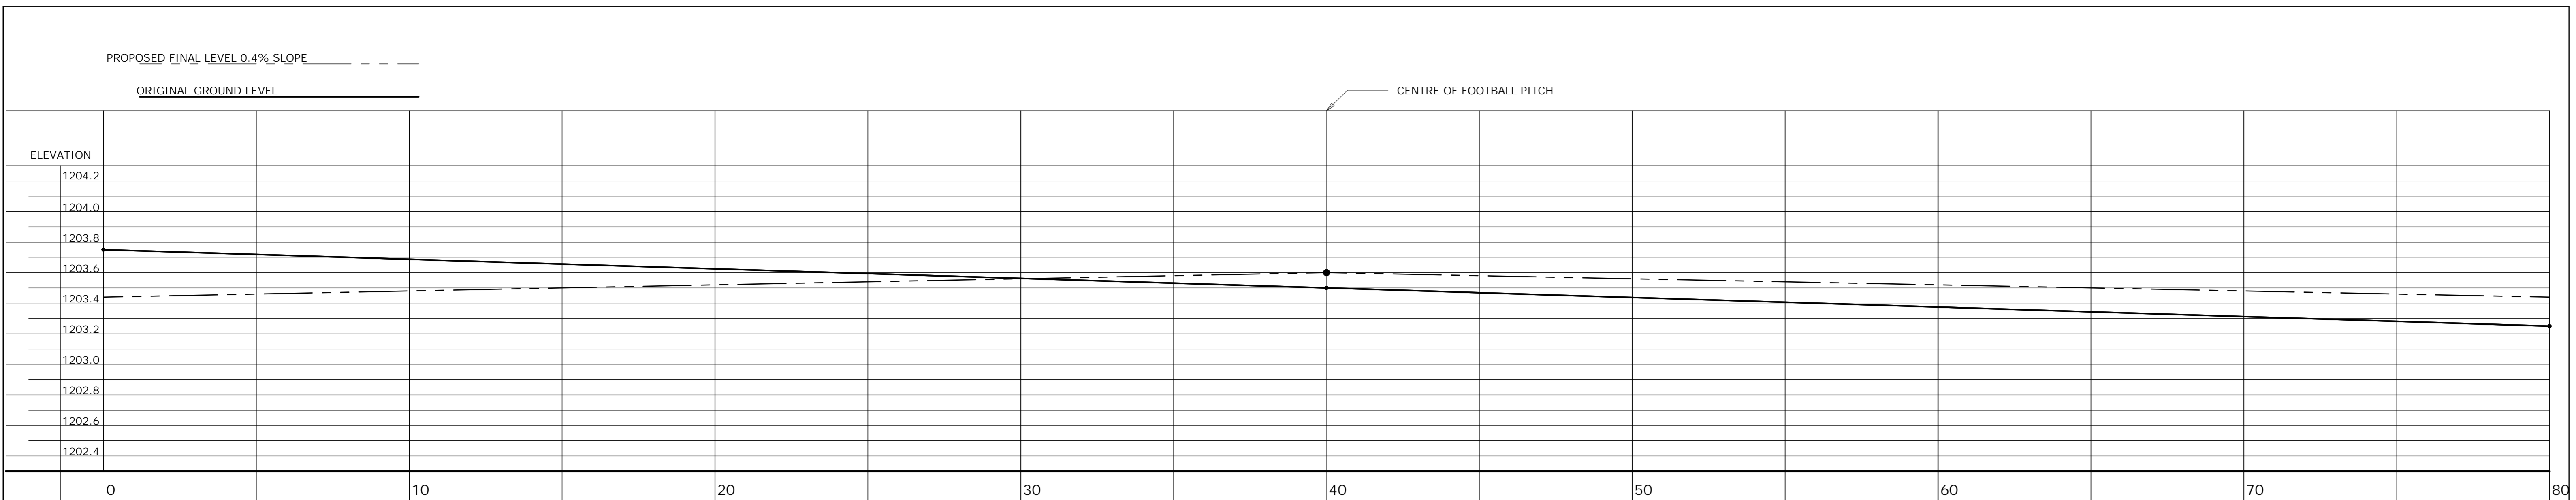




SECTION X-X THROUGH THE FOOTBALL PITCH
SCALE 1:100

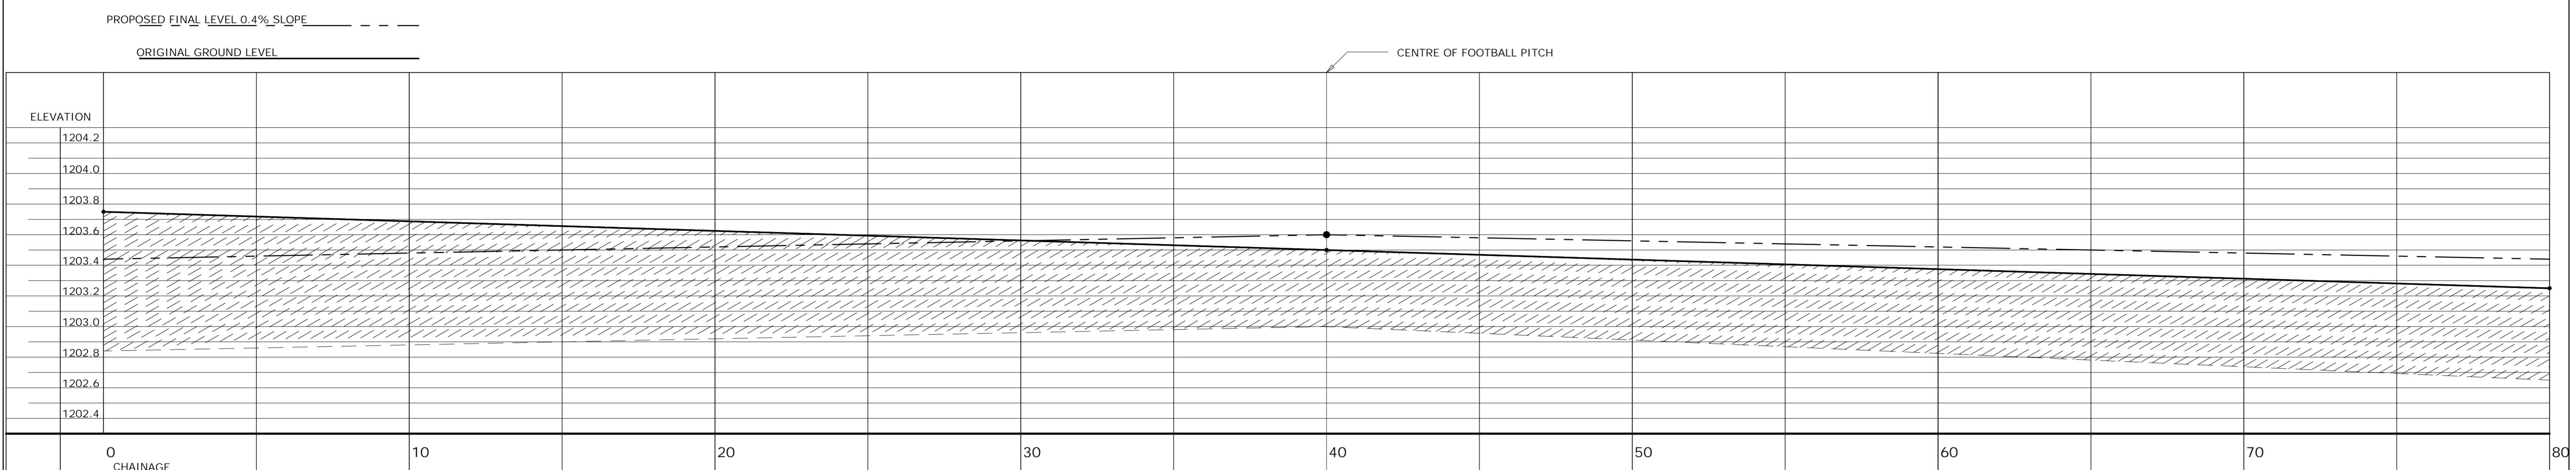

CUT
SCALE 1:100

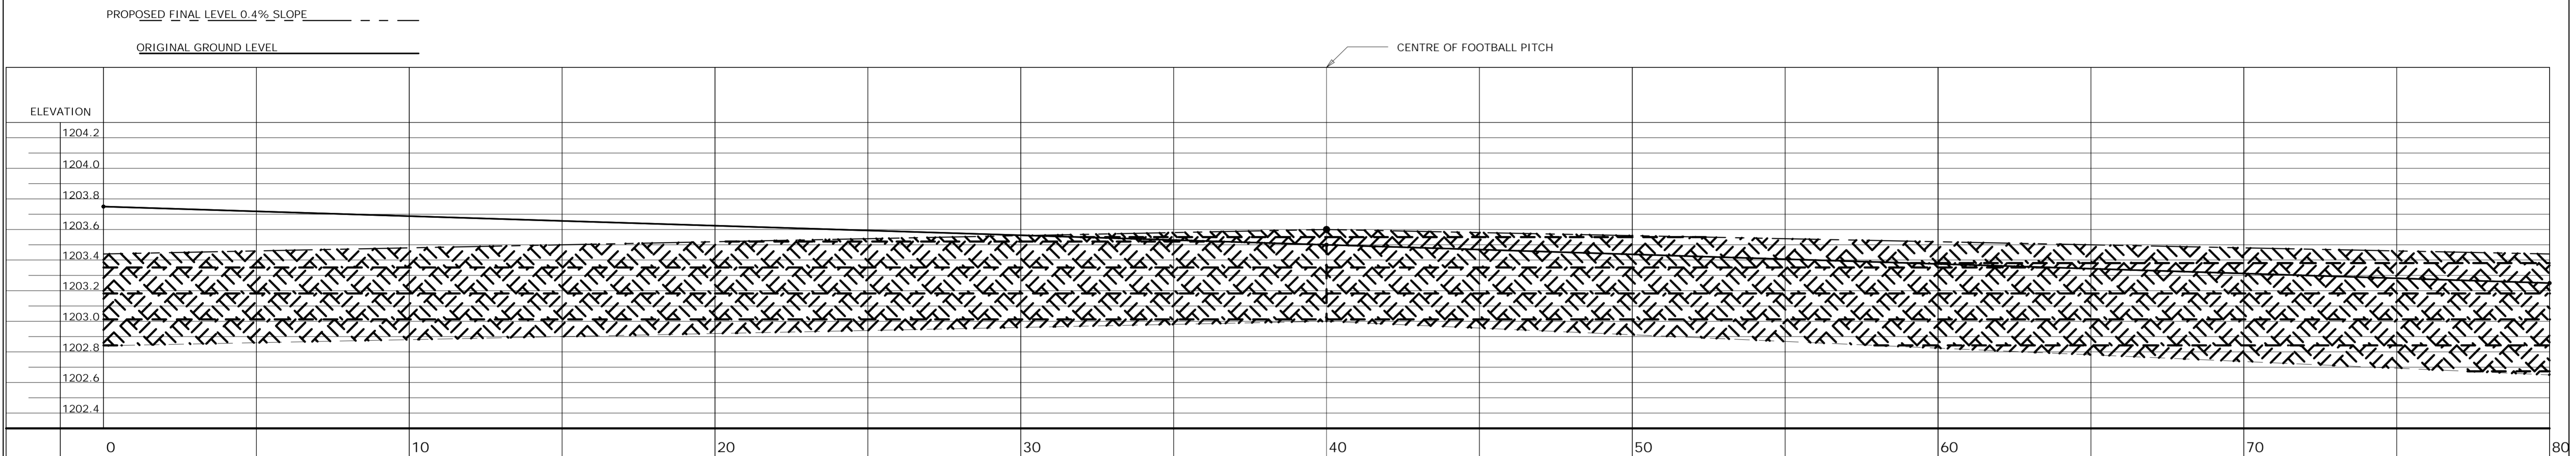

FILL
SCALE 1:100

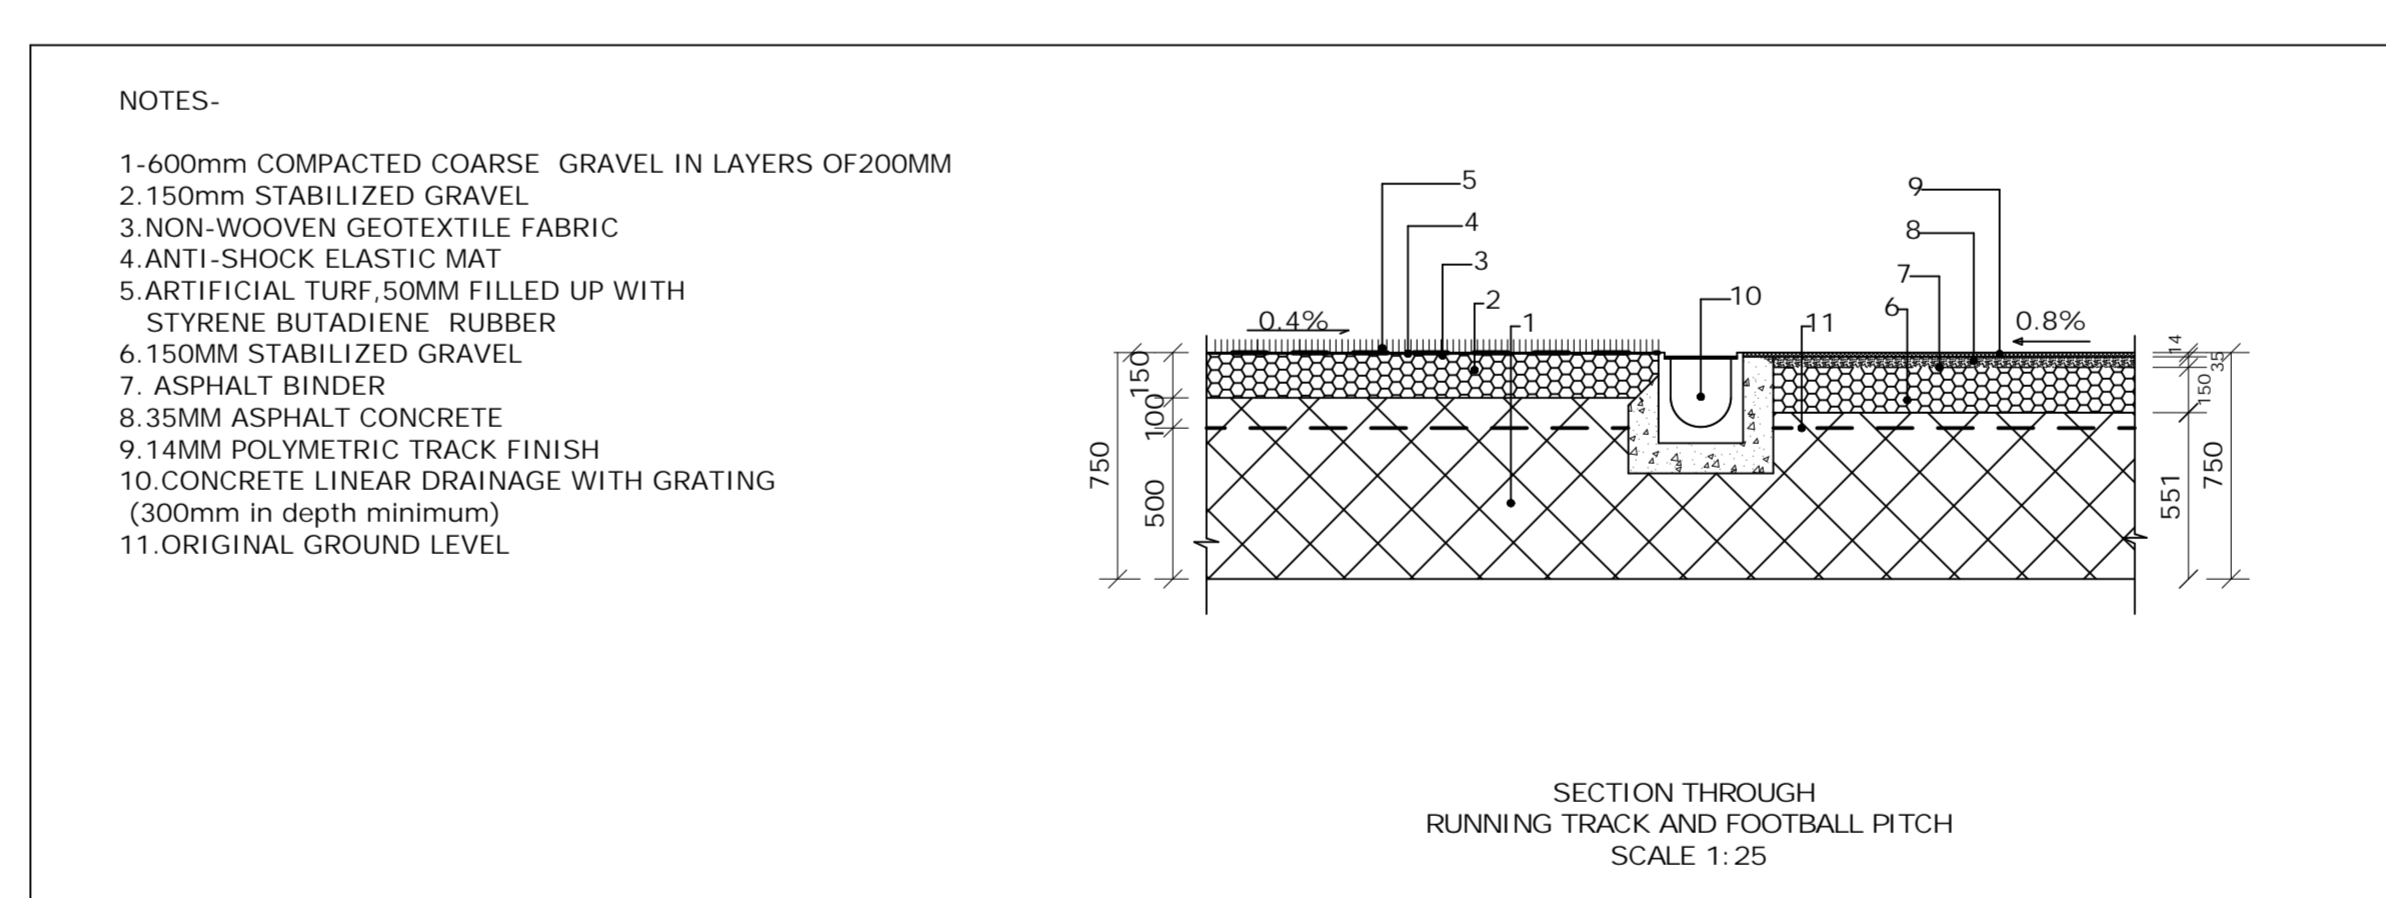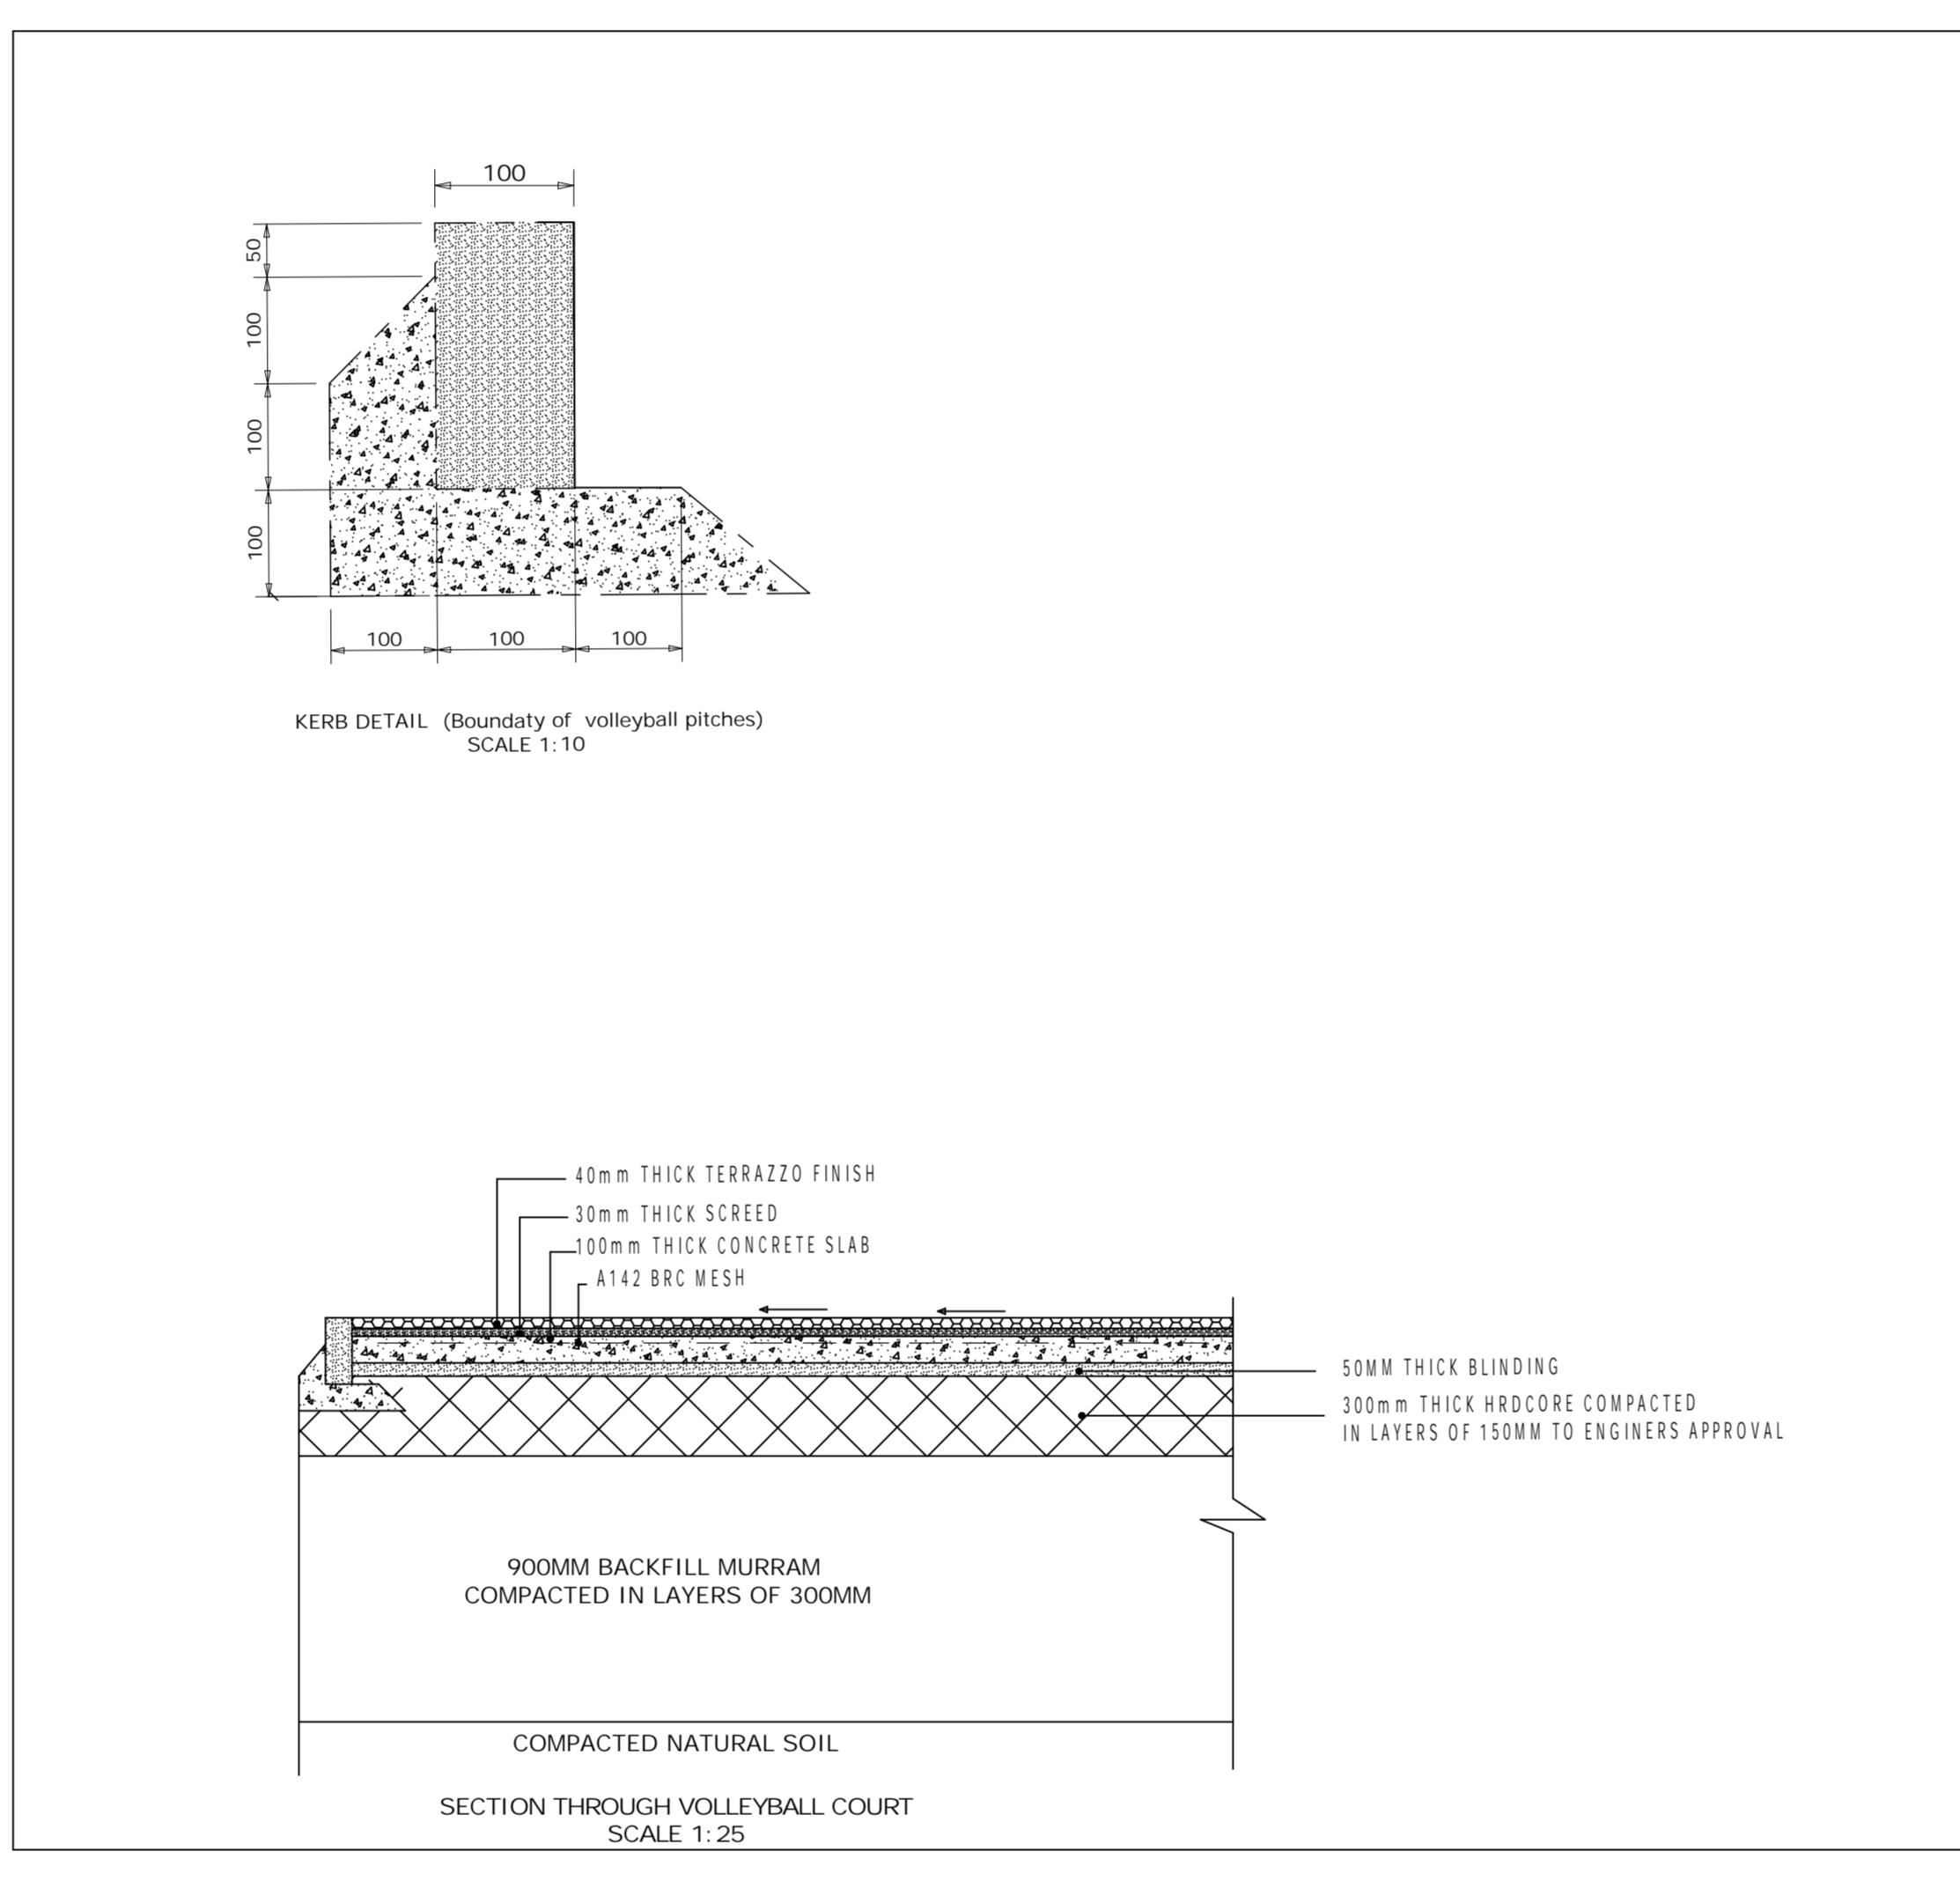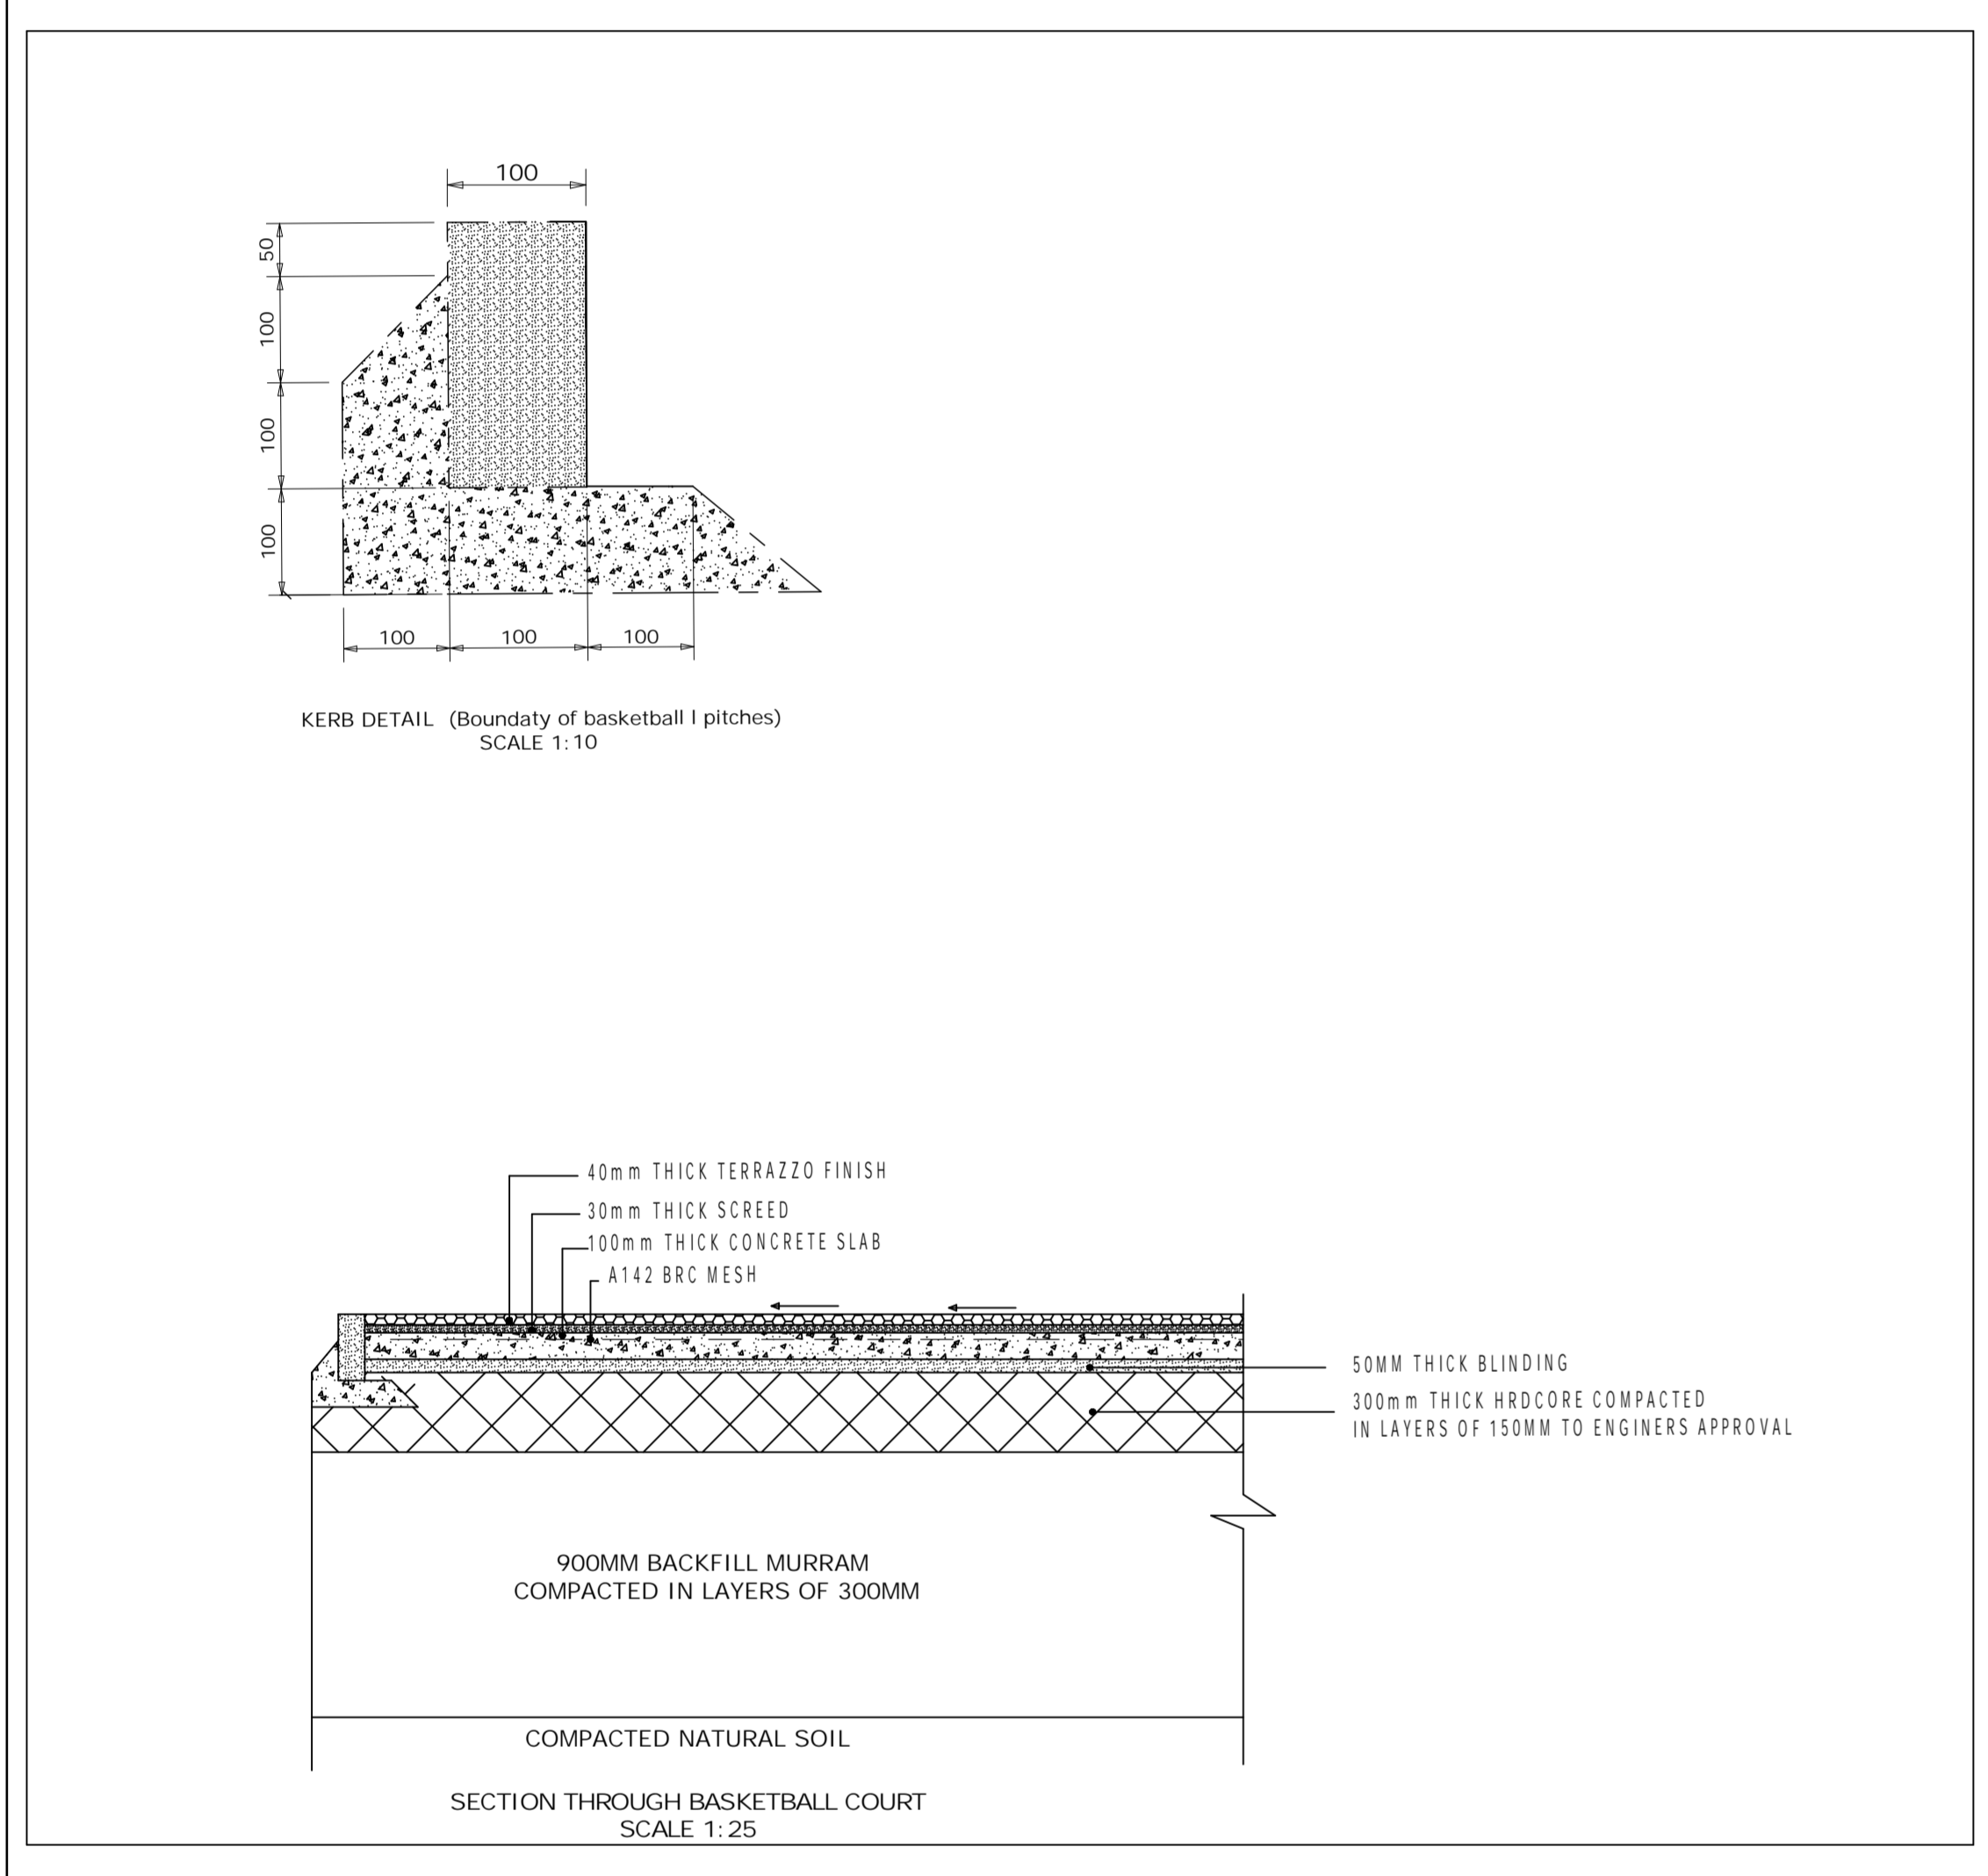

N

Notes

1. BLACK COTTON SOIL TO BE EXCAVATED TO A DEPTH OF 500MM
2. GRAVEL TO BE BACKFILLED TO A DEPTH OF 100MM, SLOPPED AS PER THE LAYOUTS

Client
MAKUENI COUNTY GOVERNMENT

DESIGNED BY
KJS

Date	July 2024
Drawn by	KJS